

# Southern Alarm Systems Ltd

Unit 25 Estate Road  
Cradle Hill Industrial Estate,  
Seaford, East Sussex. BN25 3JE

Tel: 01323 899634



Drawn - D. Pryor 12-11-2021  
Draft L4 fire alarm design proposal  
Fire extinguisher proposal

Location Plan - Scale 1:1250

The Old Station

Glynde  
East Sussex  
BN8 6SS RLL



*The licensed AREA is OUTLINED in RED*

Key:-

Fire alarm control panel **FAP**

Break glass call point **C**

Combined optical smoke detector and sounder base **SD<sup>+</sup>S**


Combined heat detector and sounder base **HD<sup>+</sup>S**

6 Litre water extinguisher **W**

2 Kg CO2 extinguisher **CO2**

Floor Plan - Scale 1:100  
The Old Station

Glynde  
East Sussex  
BN8 6SS RLL

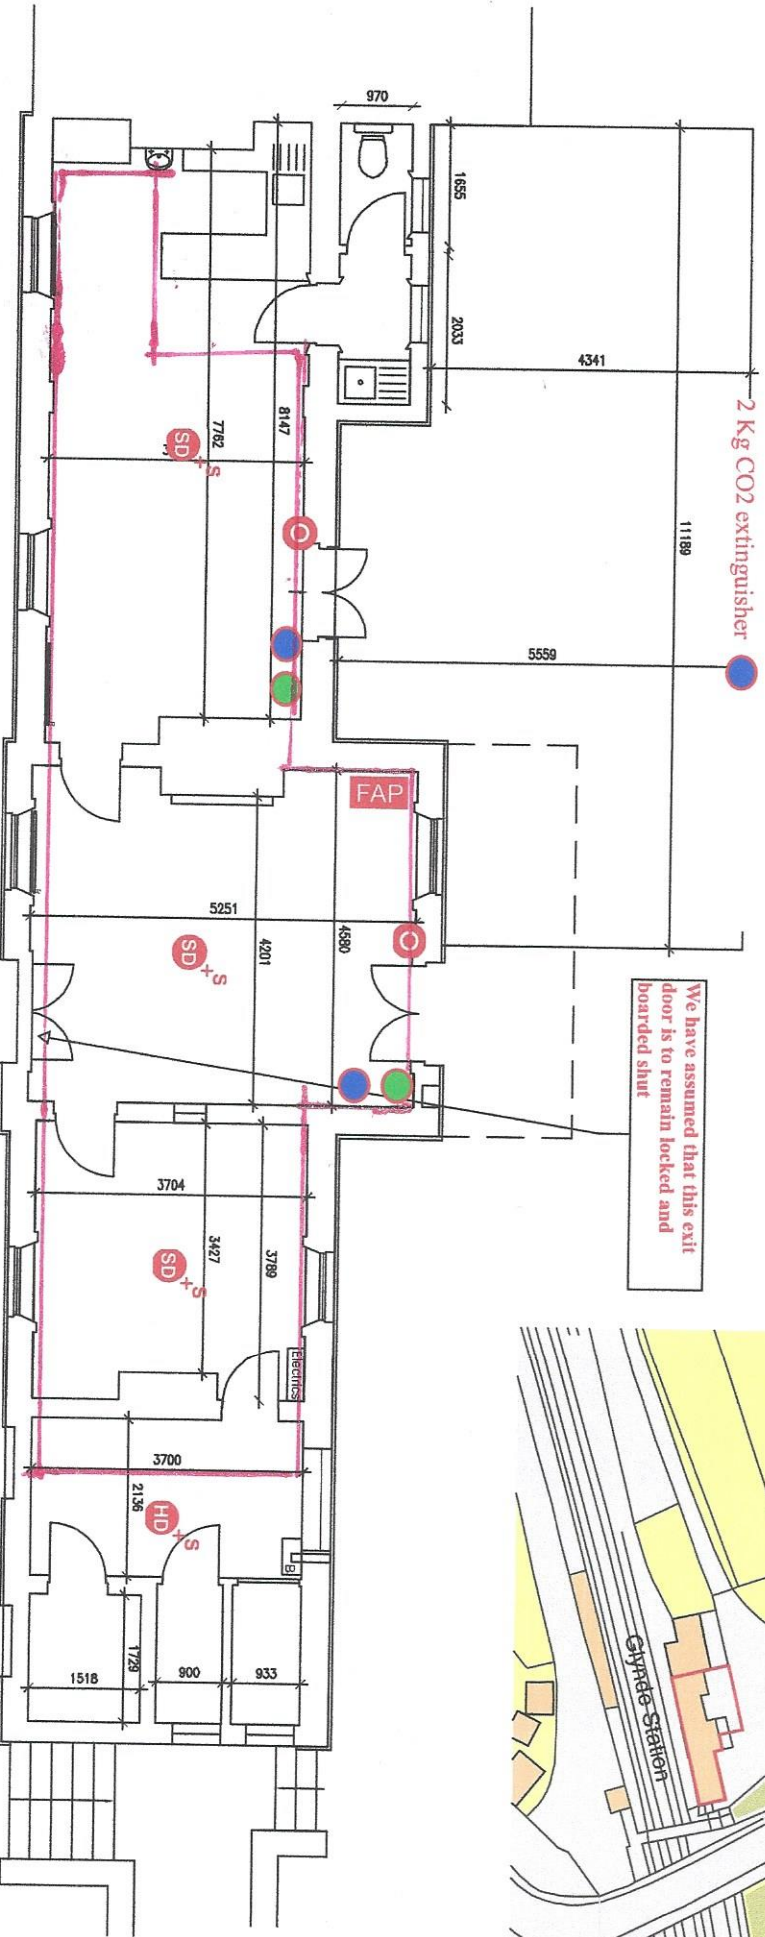

We have assumed that this exit door is to remain locked and boarded shut

